


A'Seeb SEWAGE TREATMENT PLANT PROCESS FLOW Diagram

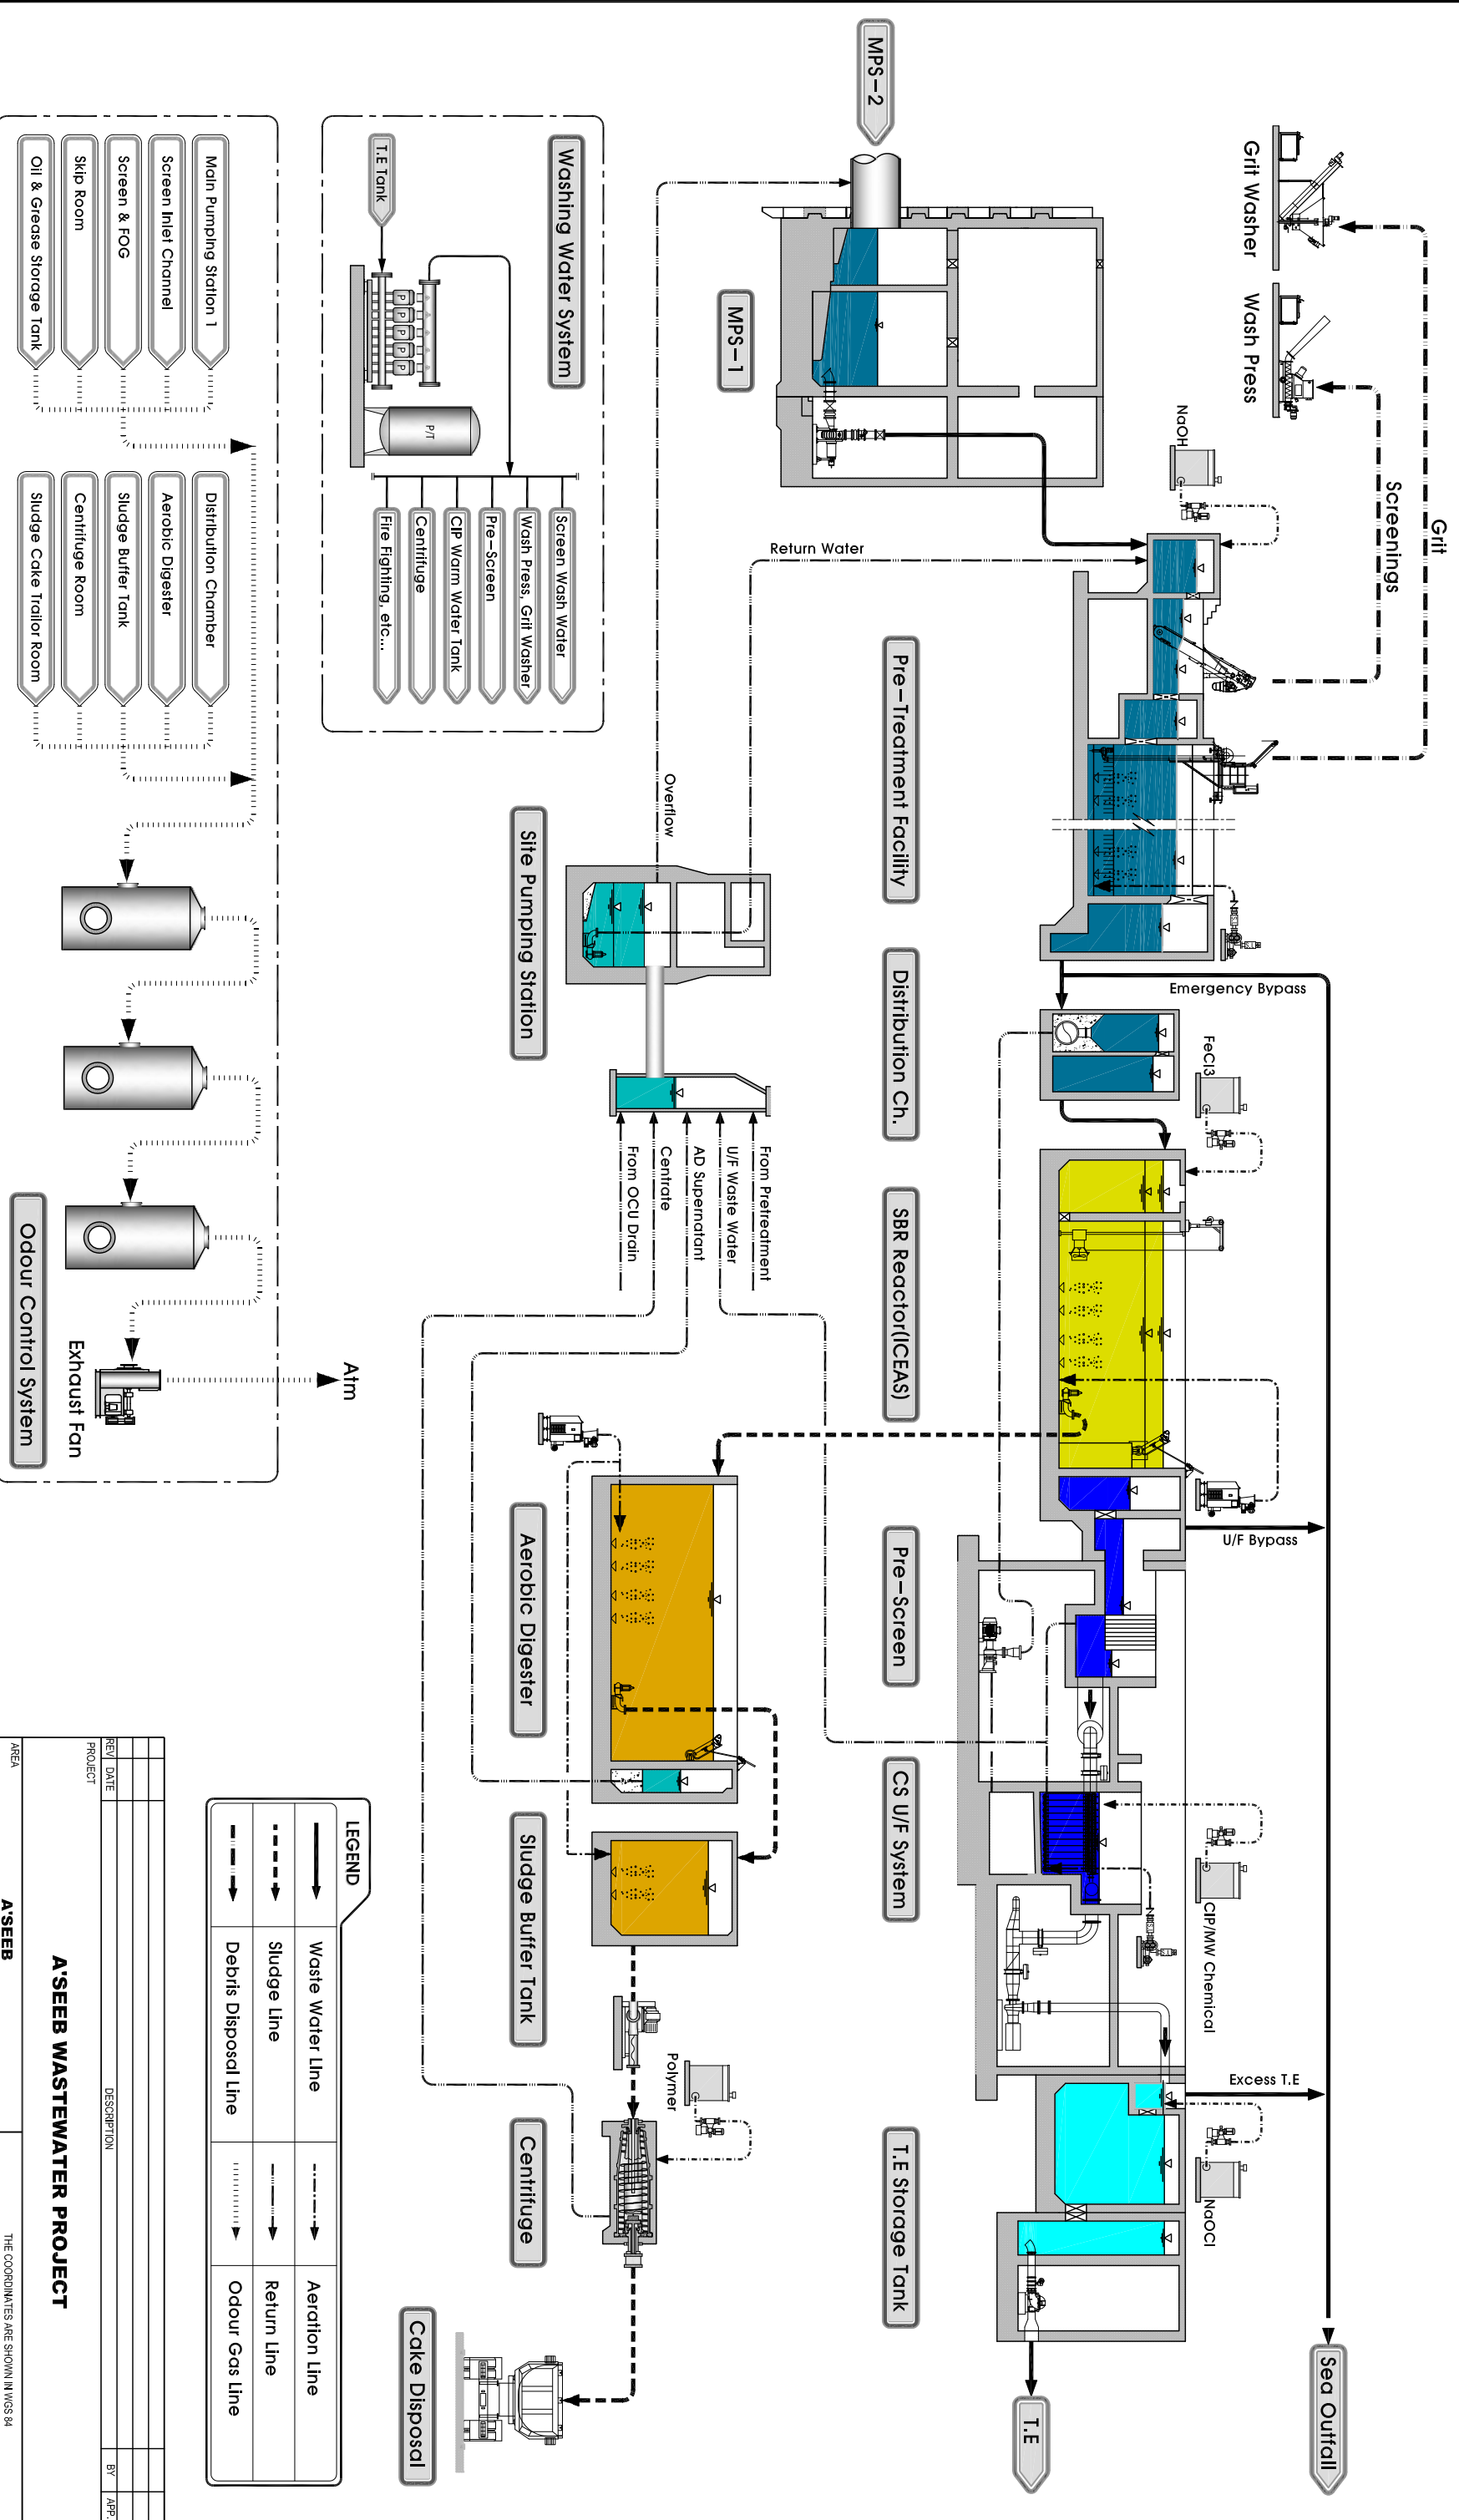

LEGEND

	Waste Water Line		Aeration Line
	Sludge Line		Return Line
	Debris Disposal Line		Odour Gas Line

A'SEEB WASTEWATER PROJECT

REV#	DATE	DESCRIPTION	BY	APP.

<p>Notes:</p>	
<p>CLIENT</p>	<p>CONSULTANT</p> <p>PARSONS INTERNATIONAL & COMPANY L.L.C.</p>
<p>CONTRACTOR</p> <p>JV OF HYUNDAI ROTEM & HYUNDAI ENGINEERING</p>	<p>DESIGNED: A'Seeb STP & Ancillary work</p> <p>SCALE: KSM</p> <p>DATE: N.T.S</p> <p>PROJECT NO.: SR2002</p> <p>SHEET NO.: A1</p>